

**Freedom of Information request reference number:** 6721.1

**Date of response:** 15/08/2022

**Request:**

- 1) *Mitcham Fire Station Floor Plan with names.*
- 2) *Detailed list of equipment in the latest DPLs and FRUs.*
- 3) *Specification of the vehicle being modified to create your new Command Units.*

**Response:**

I have attached redacted copies of the floor plans for Mitcham Fire Station to the response below. Please note that we do not typically provide a detailed breakdown of the names of each room included on a floor plan and what they contain, as they can be targeted for theft. Therefore, I would consider providing a full, labelled floor plan exempt from disclosure under the Freedom of Information Act (FOIA) under section 31(1)(a) - Law enforcement.

With regard to equipment, we do not typically provide a detailed breakdown of the equipment and where it is located on vehicles as it can be targeted for theft. Therefore, I would consider providing a full inventory of equipment stored on the latest DPLs, FRUs and Command Units exempt from disclosure under the FOIA under section 31(1)(a) - Law enforcement.

Section 31 is a qualified exemption and I must consider the public interests for and against disclosure. It is sadly the case that fire stations and appliances are targets for crime and the loss of equipment prevents the LFB from carrying out its public safety duties. I am therefore of the view that it is in the public interest not to disclose information at the detailed level you have requested.

We have dealt with your request under the Freedom of Information Act 2000. For more information about this process please see the guidance we publish about making a request on our website: <https://www.london-fire.gov.uk/about-us/transparency/request-information-from-us/>





- KEY**
- W Bd White Board
  - D Bd Display Board
  - Cpd High Cupboard - storage tambour high
  - Cpd Mid Cupboard with roller shutter high
  - Bookcase Bookcase with roller shutter high
  - Map Glazed Frames for A0 sized maps
  - Wrd Wardrobe

**Note:**  
Underground surface water attenuation tank and impact protection to be added, pending KES information.

**LFB**  
LONDON FIRE BRIGADE

**blue<sup>3</sup>**

Revision	Revision Description	Date	Checked By	Revision	Revision Description	Date	Checked By	Notes
-	First Issue							
A	LFB CP2 Issue 4	19.11.12	JB					
B	LFB CP2 Issue 4 - Revision Clouded	21.11.12	JB					
C	Access control post omitted; Door/window codes added	30.11.12	JB					
D	LFB CP2 Issue 5.	14.12.12	JB					

**BDP.**

16 Brewhouse Yard  
Clerkenwell  
London EC1V 4LJ  
United Kingdom  
T +44 (0)20 7812 8000  
F +44 (0)20 7812 8399  
www.bdp.com  
©BDP 2012


**LFB Mitcham Fire Station**  
Project Number: P2003515

Ground Floor Plan  
FFE

Scale: 1:100@A1  
Date: 12.10.12  
Revision: D

BUILDING DESIGN PARTNERSHIP LTD. SHALL HAVE NO RESPONSIBILITY FOR ANY USE MADE OF THIS DOCUMENT OTHER THAN FOR THAT WHICH IT WAS PREPARED FOR.  
DO NOT SCALE FROM THIS DRAWING. ANY ERRORS OR OMISSIONS ARE TO BE BROUGHT TO THE ATTENTION OF BDP.



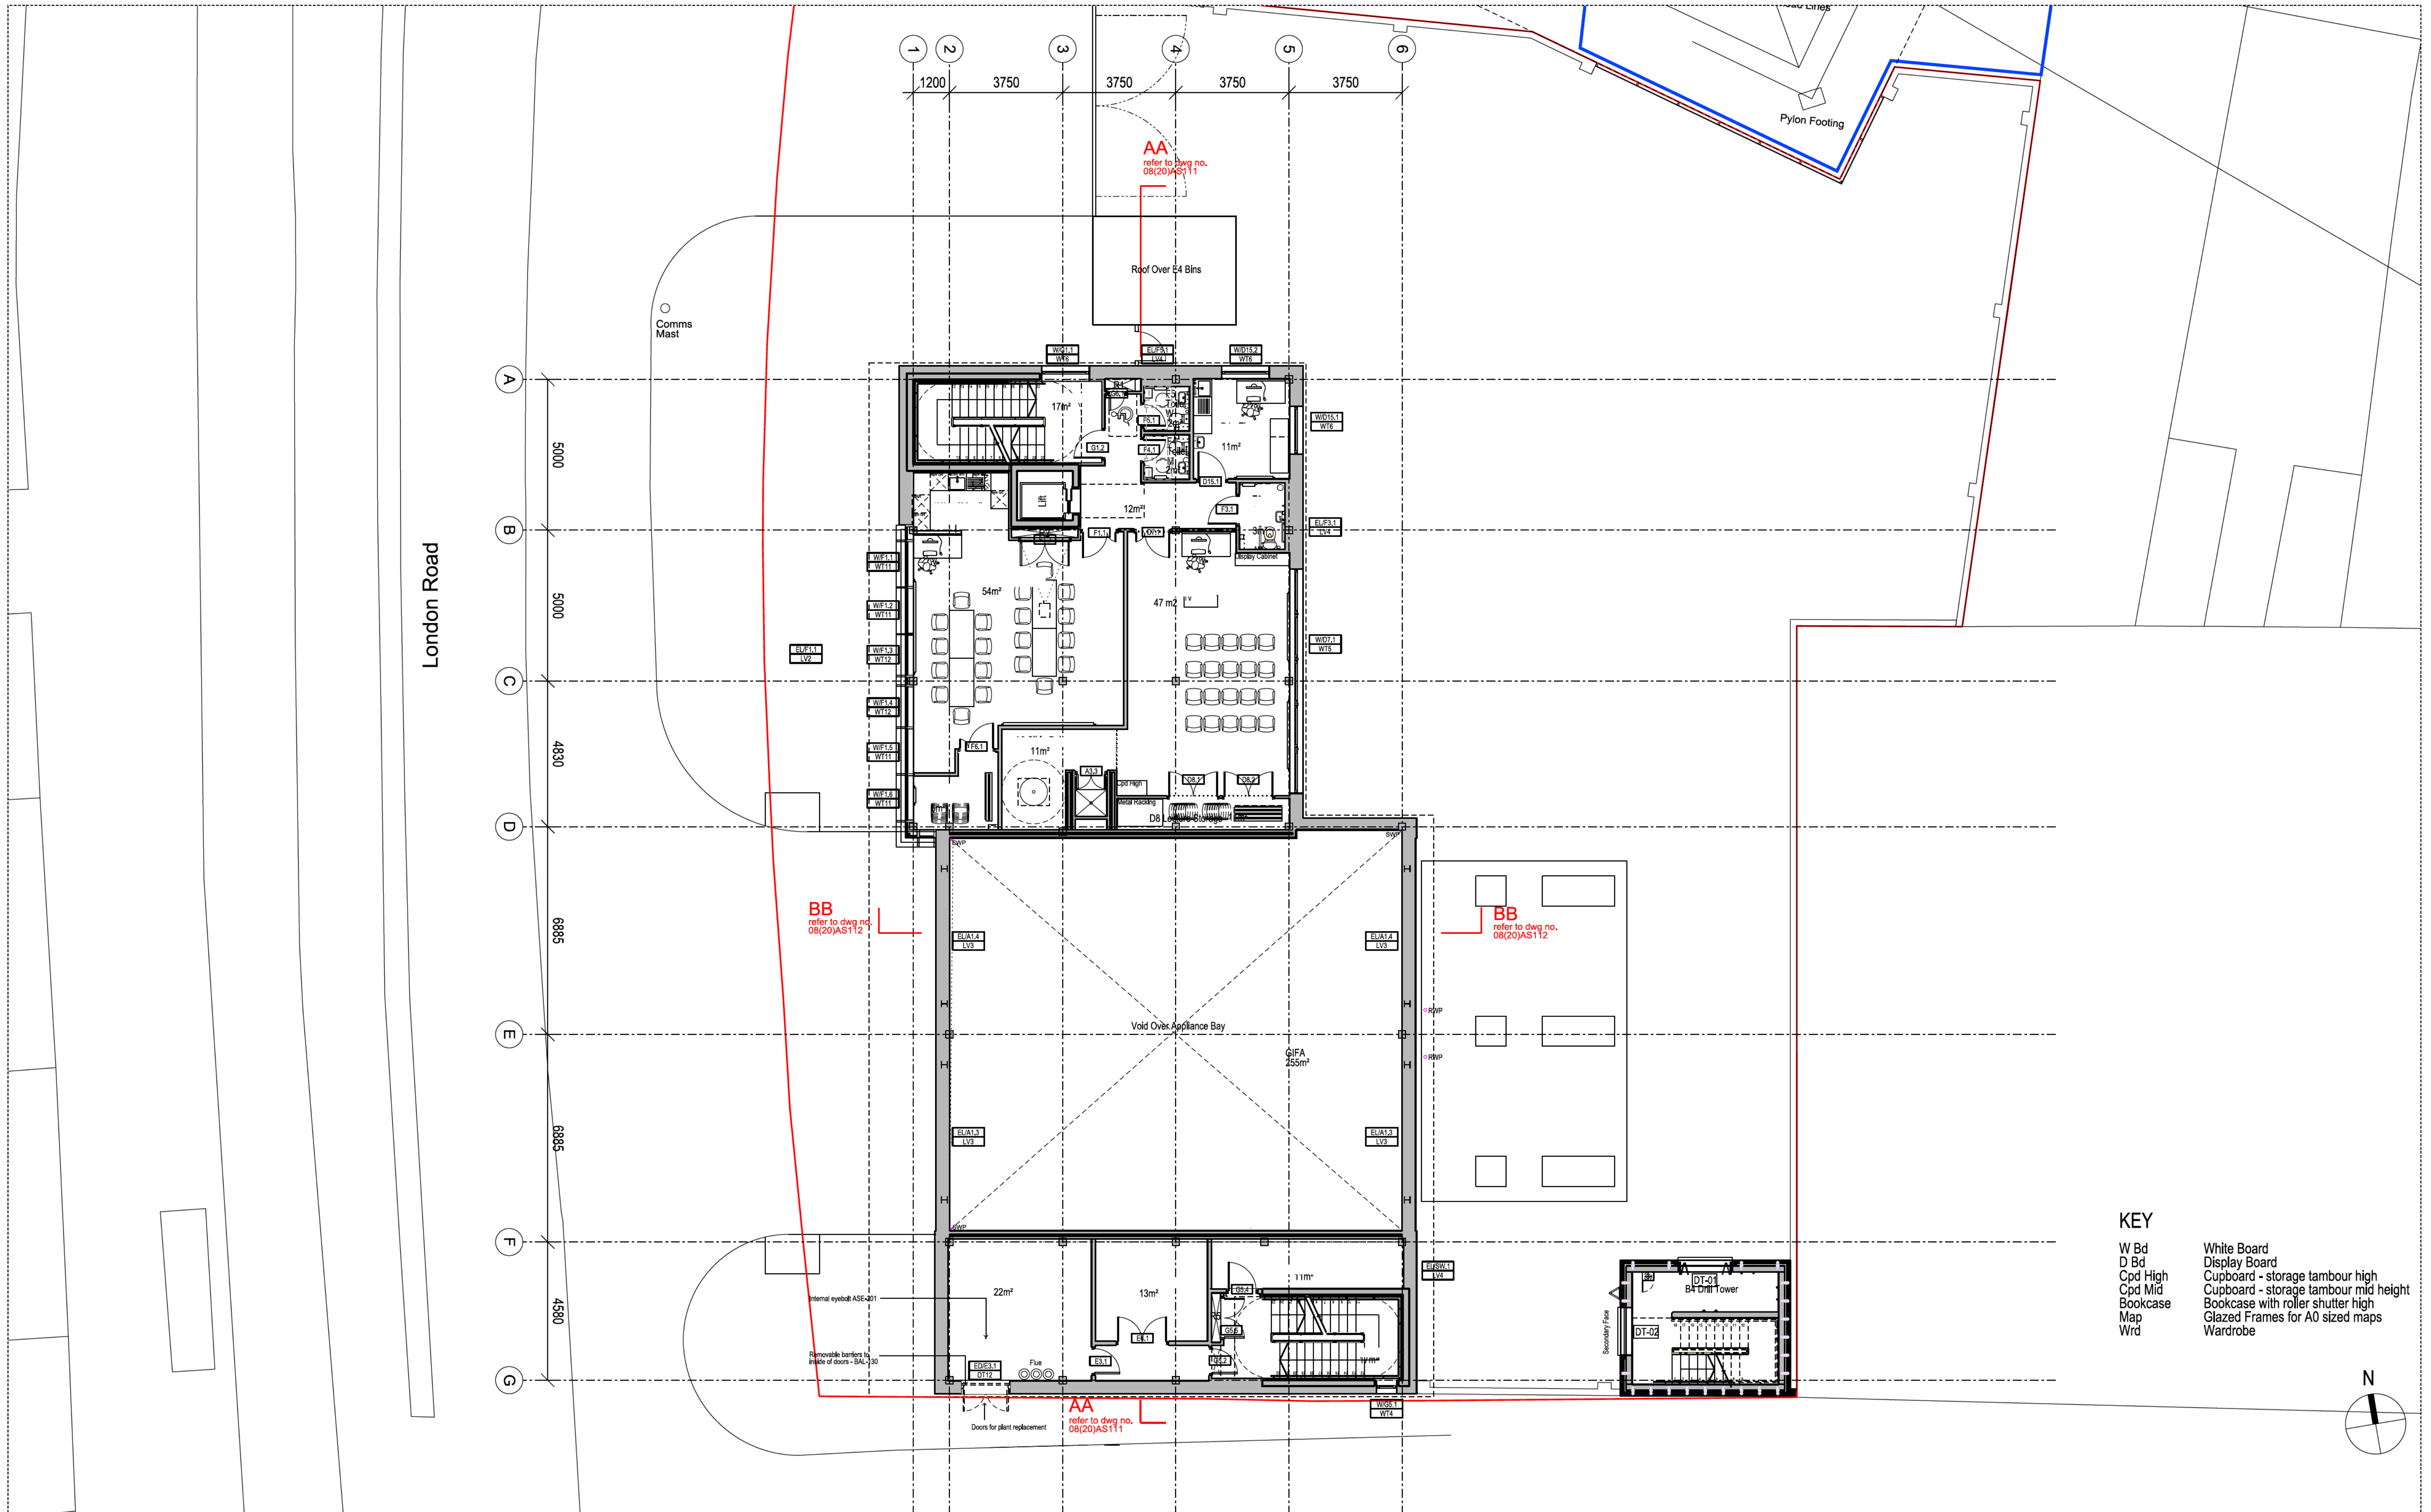

- KEY**
- W Bd White Board
  - D Bd Display Board
  - Cpd High Cupboard - storage tambour high
  - Cpd Mid Cupboard - storage tambour mid height
  - Bookcase Bookcase with roller shutter high
  - Map Map
  - Wrd Wardrobe

**LFB**  
LONDON FIRE BRIGADE

**blue<sup>3</sup>**

Revision	Revision Description	Date	Checked By	Revision	Revision Description	Date	Checked By	Notes
-	First Issue	-	-	-	-	-	-	-
A	LFB CP2 Issue 4	19.11.12	JB	-	-	-	-	-
B	LFB CP2 Issue 4	21.11.12	JB	-	-	-	-	-
C	Revisions Clouded; Door/ window codes added	30.11.12	JB	-	-	-	-	-
D	LFB CP2 Issue 5	14.12.12	JB	-	-	-	-	-

**BDP.**

16 Brewhouse Yard  
Clerkenwell  
London EC1V 4LJ  
United Kingdom  
T +44 (0)20 7812 8000  
F +44 (0)20 7812 8399  
www.bdp.com


**LFB Mitcham Fire Station**  
Project Number: P2003515

First Floor Plan  
FFE

Scale: 1:100@A1  
Date: 12.10.12  
Revision: D

BUILDING DESIGN PARTNERSHIP LTD. SHALL HAVE NO RESPONSIBILITY FOR ANY USE MADE OF THIS DOCUMENT OTHER THAN FOR THAT WHICH IT WAS PREPARED FOR.  
DO NOT SCALE FROM THIS DRAWING. ANY ERRORS/ DIVERGENCES ARE TO BE BROUGHT TO THE ATTENTION OF BDP.



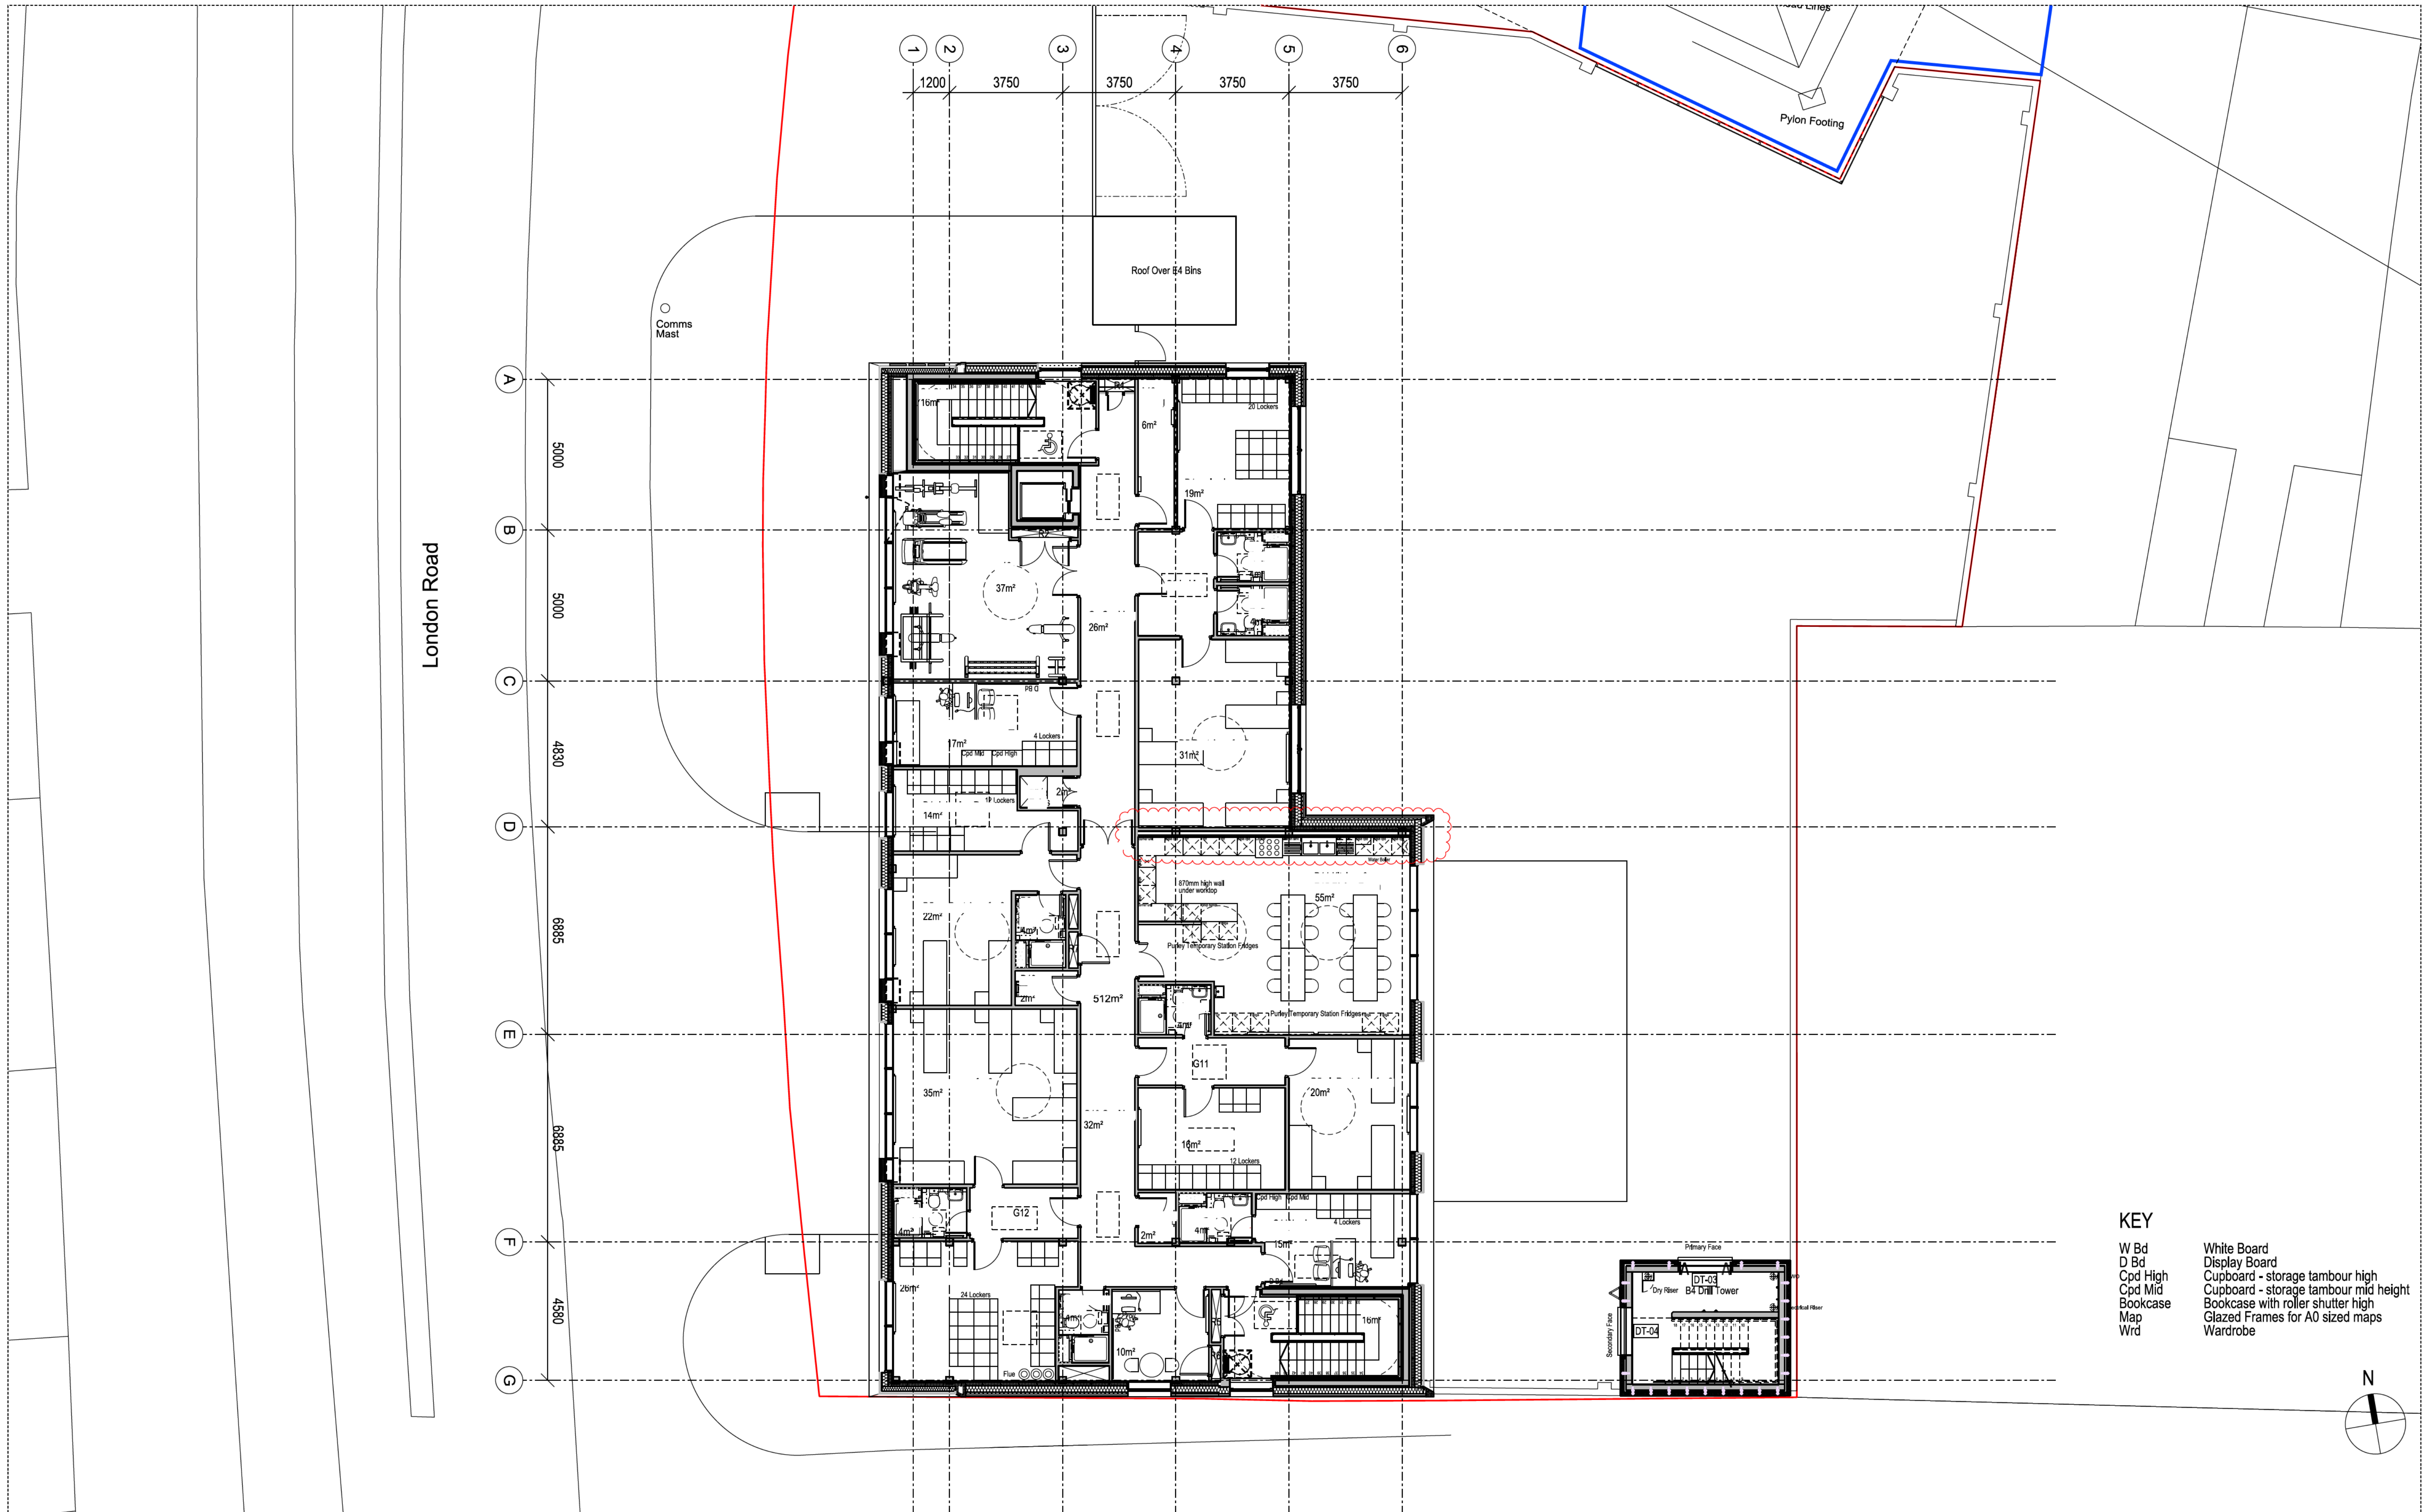

- KEY**
- W Bd White Board
  - D Bd Display Board
  - Cpd High Cupboard - storage tambour high
  - Cpd Mid Cupboard - storage tambour mid height
  - Bookcase Bookcase with roller shutter high
  - Map Glazed Frames for A0 sized maps
  - Wrdr Wardrobe

**blue<sup>3</sup>**

Key Plan

Revision	Revision Description	Date	Checked By	Revision	Revision Description	Date	Checked By	Notes
-	First Issue	-	-	-	-	-	-	
A	LFB CP2 Issue 4	19.11.12	JB					
B	LFB CP2 Issue 4	21.11.12	JB					
C	Door/window numbers added	30.11.12	JB					
D	LFB CP2 Issue 5	14.12.12	JB					

**BDP.**

16 Brewhouse Yard  
Clerkenwell  
London EC1V 4LJ  
United Kingdom  
T +44 (0)20 7812 8000  
F +44 (0)20 7812 8399  
www.bdp.com  
©BDP 2012

**LFB Mitcham Fire Station**

Project Number: P2003515

ISSUE: 1:100@A1

DATE: 08.10.12

REVISION: D

08(80) A012

BUILDING DESIGN PARTNERSHIP LTD SHALL HAVE NO RESPONSIBILITY FOR ANY USE MADE OF THIS DOCUMENT OTHER THAN FOR THAT WHICH IT WAS PREPARED FOR. DO NOT SCALE FROM THIS DRAWING. ANY ERRORS/CONTRADICTIONS ARE TO BE BROUGHT TO THE ATTENTION OF BDP.